

red dashed line is fire compartmentation

THIS DRAWING AND CAD DATA THEREIN IS PROTECTED BY COPYRIGHT AND MUST NOT BE COPIED OR REPRODUCED WITHOUT THE WRITTEN CONSENT OF OWLarchitecture.com

NO DIMENSIONS ARE TO BE SCALED FROM THIS DRAWING. USE FIGURED DIMENSIONS ONLY. ALL DIMENSIONS AND SIZES ARE TO BE CHECKED ON SITE AND ANY DISCREPANCIES REPORTED TO THE ARCHITECT PRIOR TO INITIATION OF ANY WORKS.

1 **001 Block Grd Floor Plan**
 1 : 200 Blue lines show proposed new works

Job Name
 St Oswalds Primary School
 Cross Lane Great Horton
 Bradford, BD7 3JT

Drawing Title
 Ground Floor Fire Plan

Status
 Proposal December 2013

Sheet By
 GJW

Scale at A3 - double scale at A1
 1 : 200

Job Number
 1237

Drawing Number
 FP_02


Issued Date
 15/01/2014

Tel: 0845 838 6000
 Fax: 0845 838 1805

Hammock Chase
 Alwoodley
 Leeds
 LS17 7PD
 West Yorkshire

OWLarchitecture.com

Scale set for printing at A3 thus the Scale is Doubled at A1. For example; A drawing set to print at Scale 1:200 at A3 becomes scale 1:100 when it is printed at A1.

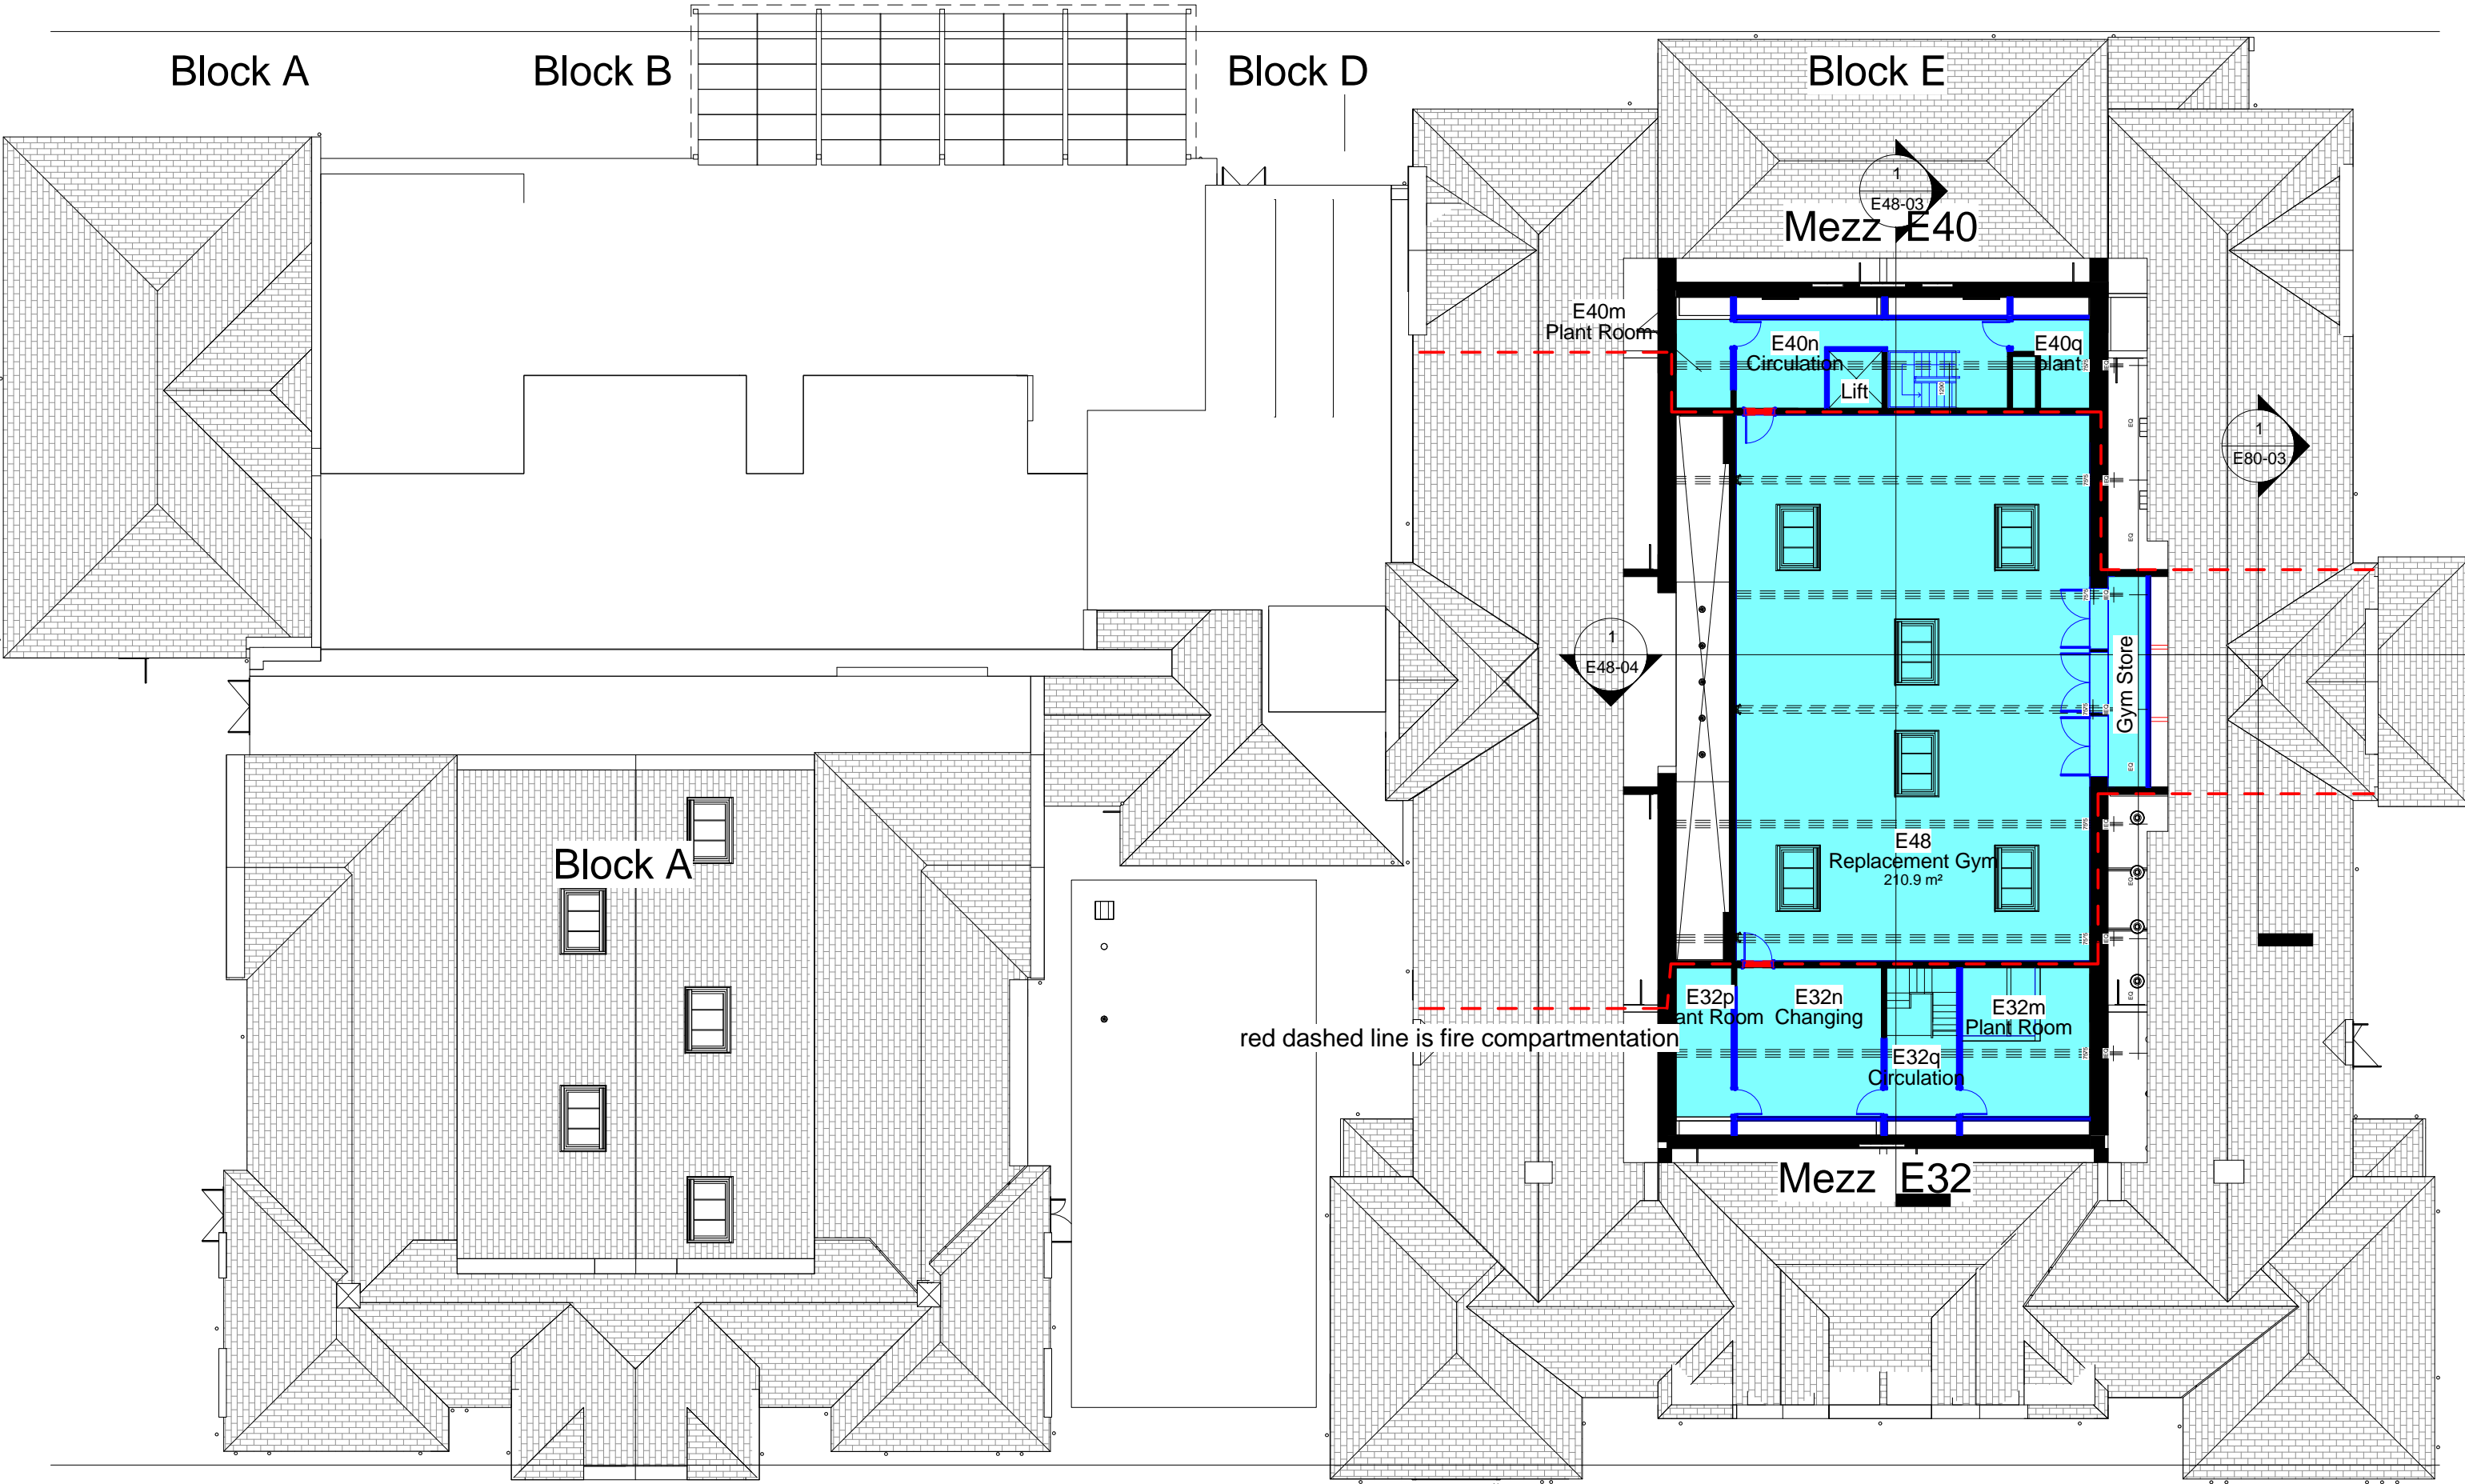

red dashed line is fire compartmentation

THIS DRAWING AND CAD DATA THEREIN IS PROTECTED BY COPYRIGHT AND MUST NOT BE COPIED OR REPRODUCED WITHOUT THE WRITTEN CONSENT OF OWLarchitecture.com

NO DIMENSIONS ARE TO BE SCALED FROM THIS DRAWING. USE FIGURED DIMENSIONS ONLY. ALL DIMENSIONS AND SIZES ARE TO BE CHECKED ON SITE AND ANY DISCREPANCIES REPORTED TO THE ARCHITECT PRIOR TO INITIATION OF ANY WORKS.

1 **001 Block Mezz Floor Plan**
1 : 200

Job Name
St Oswalds Primary School
Cross Lane Great Horton
Bradford, BD7 3JT

Drawing Title
Mezz Fire Alarm Plan

Status
Proposal December 2013

Sheet By
GJW

Scale at A3 - double scale at A1
1 : 200

Job Number
1237

Drawing Number
FP_03

Issued Date
15/01/2014



Tel: 0845 838 6000
Fax: 0845 838 1805

Hammock Chase
Alwoodley
Leeds
LS17 7PD
West Yorkshire

OWLarchitecture.com